



RIDGEMONT DR. BRIDGE OVER COUNTY HOUSE BRANCH FOR CITY OF COLUMBIA, MISSOURI

BRIDGE NO. 930011
50' BRIDGE & ASPHALT SURFACE

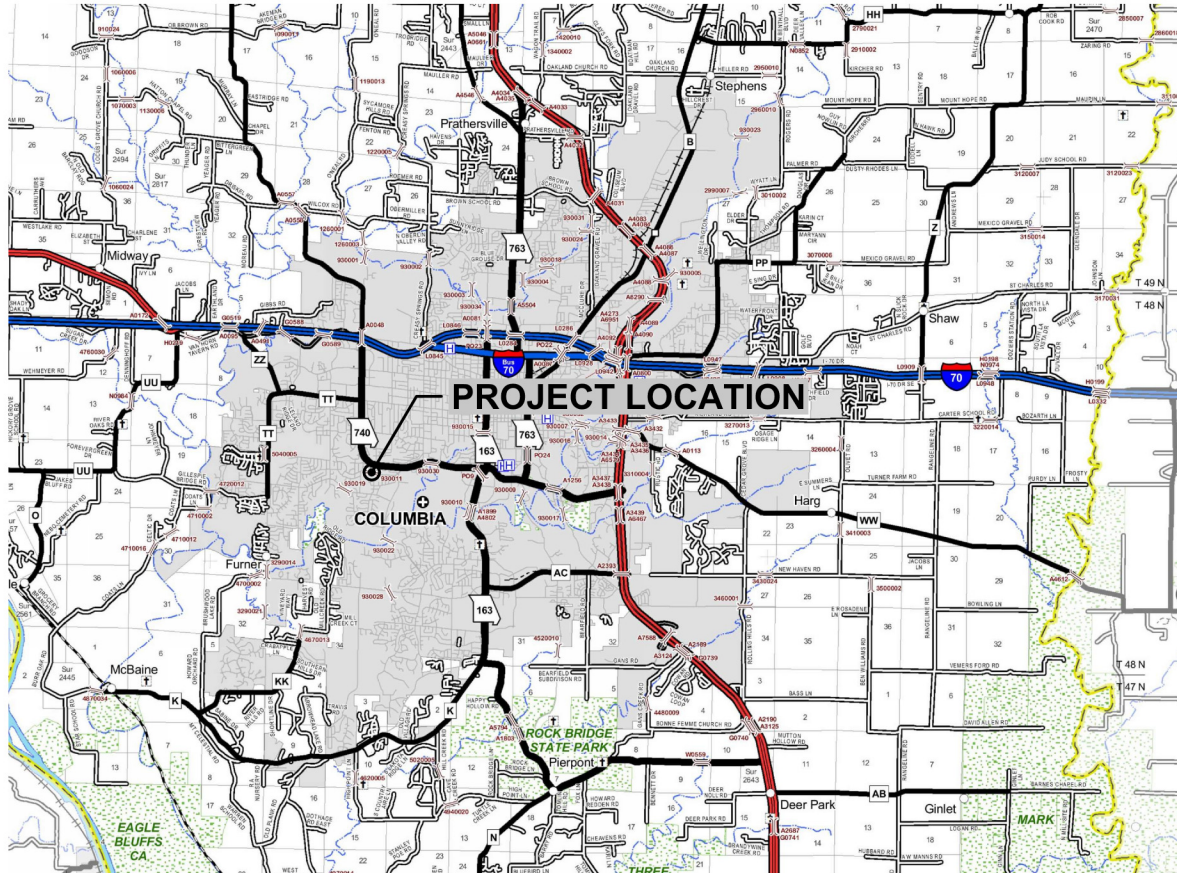

SECTION 22, T48N, R13W

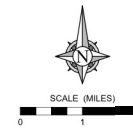

COUNTY BOONE
ROUTE RIDGEMONT DR.
PROJECT _____
JOB NO. 20KC40008

DESIGN DESIGNATION
ADT (2020) 1000
DESIGN ADT. (2040) 1500
AADT TRUCK 3%
DESIGN SPEED 25 MPH
D (DIRECTION) 50%

FUNCTIONAL CLASSIFICATION
LOCAL

LENGTH OF PROJECT
BEGINNING OF PROJECT 8+99.92
END OF PROJECT 11+05.05
APPARENT LENGTH 205.13 FEET
EQUATIONS & EXCEPTIONS _____
TOTAL CORRECTIONS _____
NET LENGTH OF PROJECT 0.04 MILES
STATE LENGTH _____
FEDERAL LENGTH 0.1 MILES

INDEX OF SHEETS		SHEET NO.
COVER SHEET		1
TYPICAL SECTIONS		2
PLAN & PROFILE		3
GRADING & EROSION CONTROL PLAN		4
TRAFFIC CONTROL PLAN		5
STORM PLAN & PROFILES		6-7
SANITARY PLAN & PROFILES		8
GENERAL NOTES & QUANTITIES		9
BRIDGE PLAN & PROFILE		10
END BENT 1		11-13
END BENT 2		14-16
BEARING PAD ASSEMBLY		17
FRAMING PLAN		18
DETAILS OF PRESTRESSED PANELS		19
SLAB - PLAN & DETAILS		20
TYPE D BARRIER		21
TYPE D BARRIER AT END BENTS		22
BILL OF REINFORCING STEEL		23
RIGHT-OF-WAY PLAN		24
CROSS SECTIONS		25
DETAILS		26-28

CALL OR CLICK 3 DAYS BEFORE YOU DIG!
MISSOURI
1-800-DIG-RITE on 811
www.motcall.com




CAUTION:
INFORMATION ON THIS DRAWING CONCERNING TYPE & LOCATION OF UNDERGROUND & OTHER UTILITIES IS NOT GUARANTEED TO BE ACCURATE OR ALL INCLUSIVE. THE CONTRACTOR IS RESPONSIBLE FOR MAKING HIS OWN DETERMINATION AS TO THE TYPE & LOCATION OF UNDERGROUND & OTHER UTILITIES AS MAY BE NECESSARY TO AVOID DAMAGE THERETO.

CONSULTANT
SUBMITTED _____ DATE _____
PROJECT ENGINEER _____ DATE _____
COUNTY
SUBMITTED _____
COUNTY COMMISSIONER _____ DATE _____



NO.	DESCRIPTION	DRAWING INFO.			
		DATE	FIELD BY	CHECK BY	DATE


COVER SHEET
RIDGEMONT DR. BRIDGE OVER
COUNTY HOUSE BRANCH
SEC. 22 T48N, R13W
CITY OF COLUMBIA, MISSOURI
SHEET NUMBER **01** OF **28**

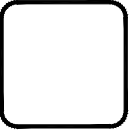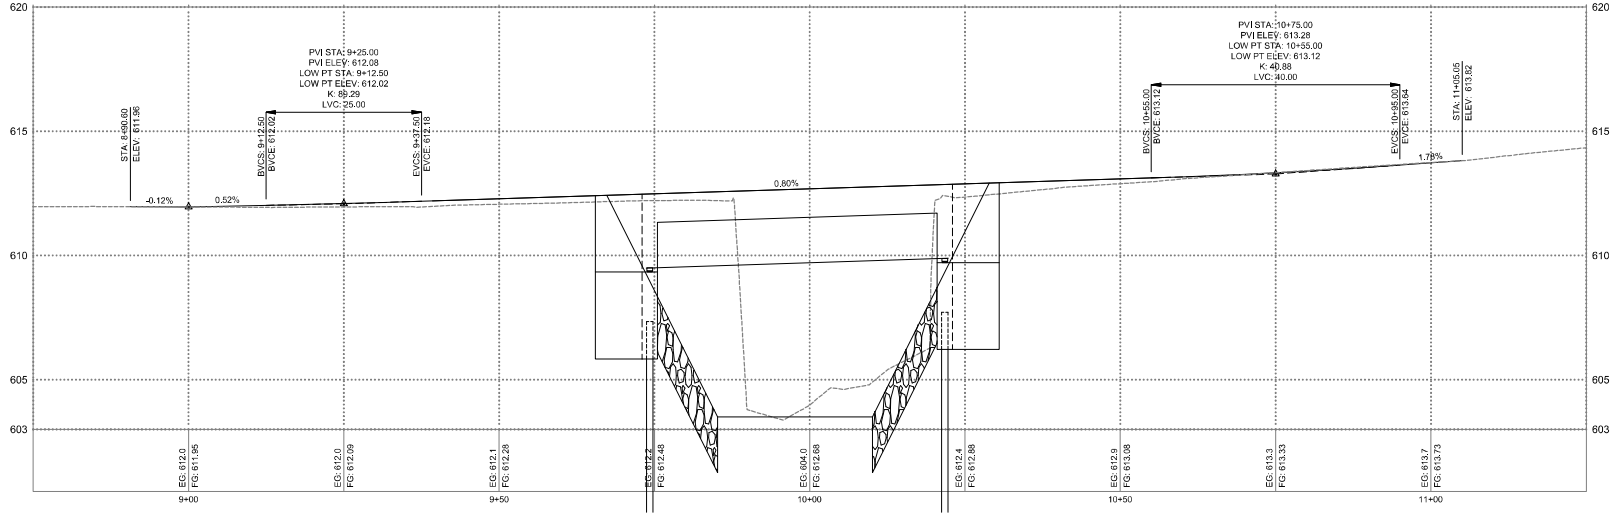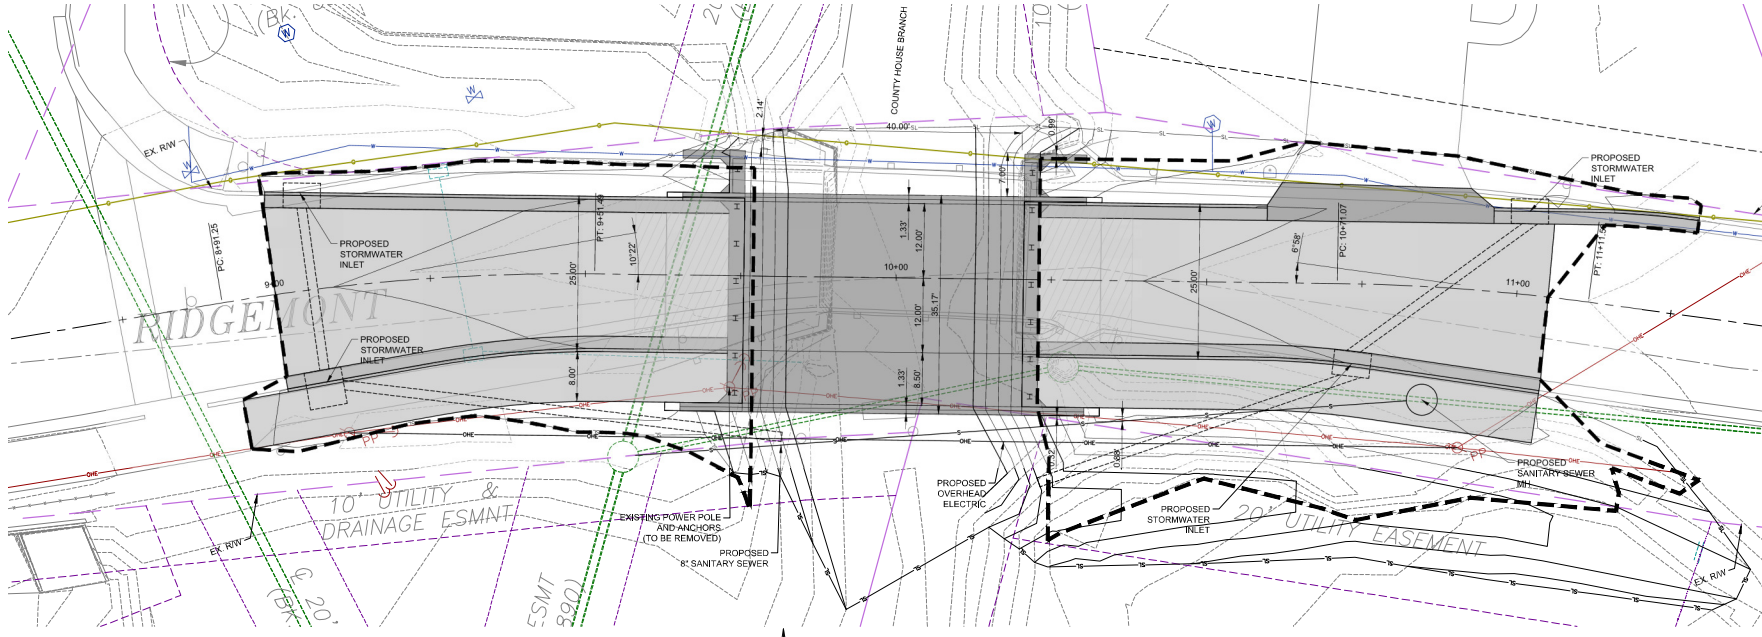

REVISIONS		DRAWING INFO.			
NO.	DESCRIPTION	BY	DATE	REG. BY:	REG. NO.:
				DESIGNER:	
				CHECKER:	
				DATE:	
				FIELD BOOK:	
				JOB NUMBER:	
				DATE PLOTTED:	

SHEET NUMBER **03** OF **28**
 PLAN & PROFILE
 RIDGEMOUNT DR. BRIDGE OVER
 COUNTY HOUSE BRANCH
 SEC. 22 T48N. R13W
 CITY OF COLUMBIA, MISSOURI

DATE PLOTTED: 10/27/2021 10:58:52 AM PLOT BY: JACOBSON

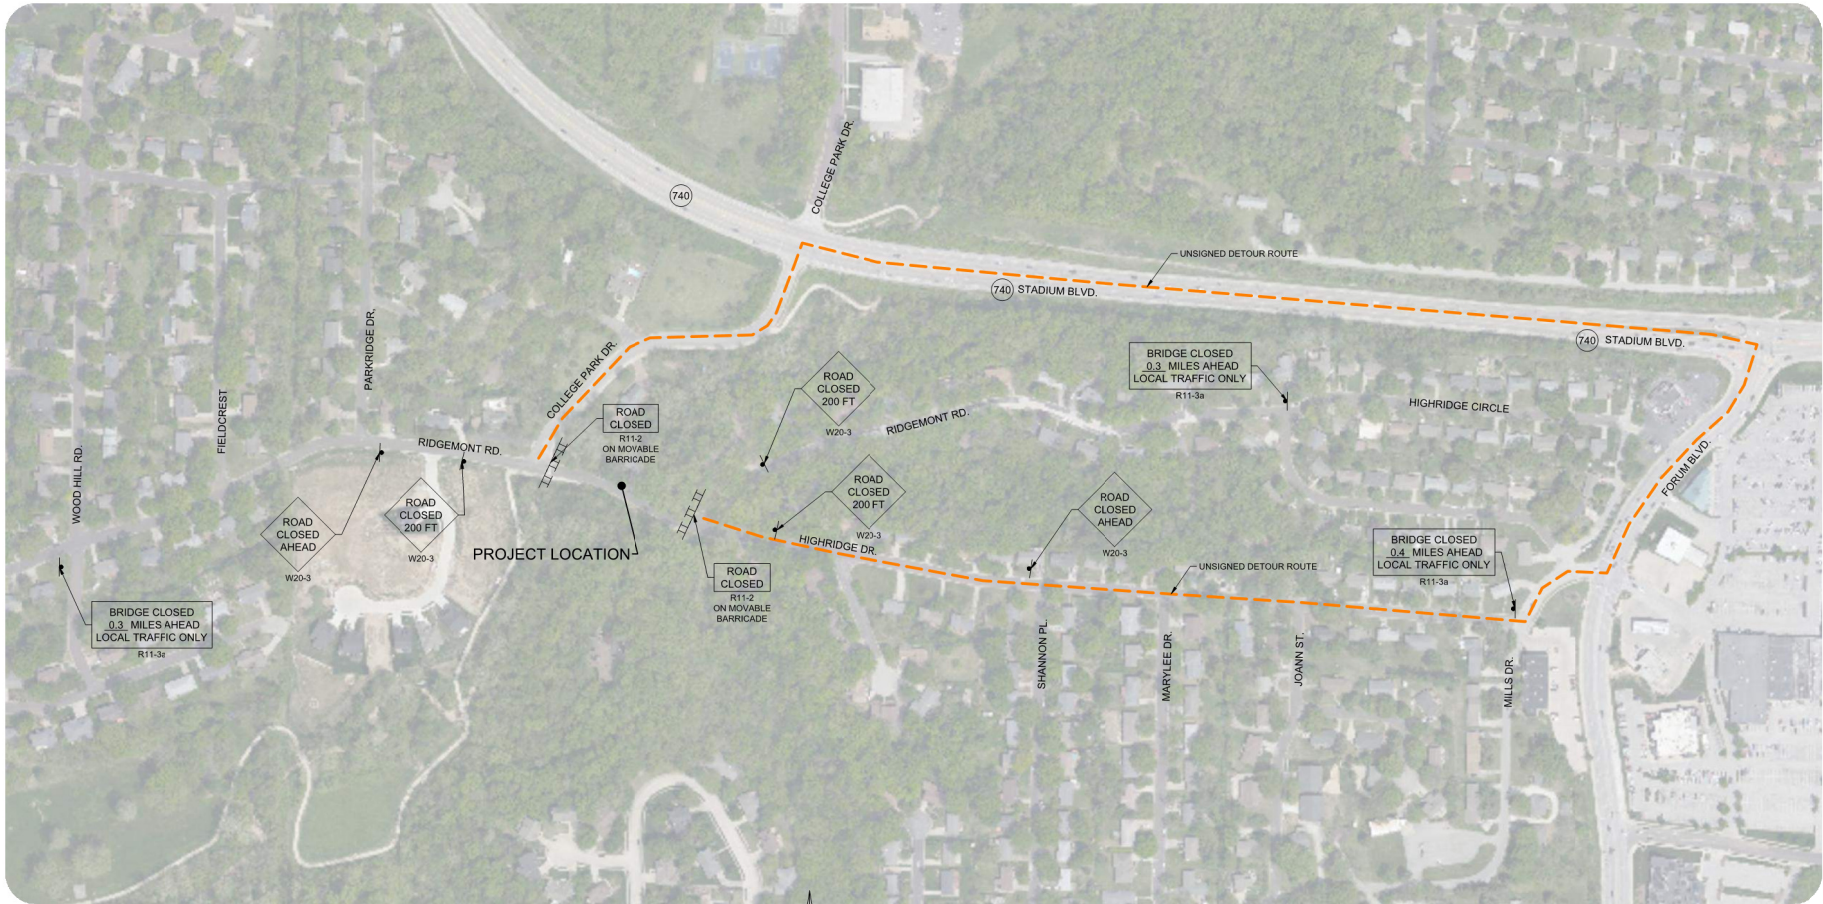


NOTES:
 TRAFFIC CONTROL SHALL COMPLY WITH THE MUTCD (2009) WITH REVISION NUMBERS 1 AND 2, AND WITH MISSOURI STANDARD SPECIFICATIONS FOR HIGHWAY CONSTRUCTION (2020)

SIGNING QUANTITIES				
SIGN	SIZE (IN)	AREA (S.F.)	QTY.	TOTAL AREA (S.F.)
R11-2	48x30	10.00	2	20.00
R11-3a	60x30	12.50	2	25.00
WO20-1	48x48	16.00	1	16.00
TOTAL				61.00

MOVABLE BARRICADE 6

LEGEND	
	UNSIGNED LOCAL DETOUR
	SIGN
	MOVABLE BARRICADE

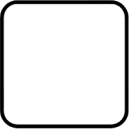

REVISIONS		DRAWING INFO	
NO.	DESCRIPTION	DATE	FIELD NO.

DATE: 10/27/2021
 JOB NUMBER: 2016C40001
 COUNTY HOUSE BRANCH
 SEC. 22 T48N, R13W
 CITY OF COLUMBIA, MISSOURI

TRAFFIC CONTROL

RIDGEMONT DR. BRIDGE OVER
 COUNTY HOUSE BRANCH
 SEC. 22 T48N, R13W
 CITY OF COLUMBIA, MISSOURI

05

OF 28