



P:\GENERAL PROJECTS\16733-APP-GENTRYIV-REVIEW\CAD\16733 CONCEPT.DWG 8/13/2025

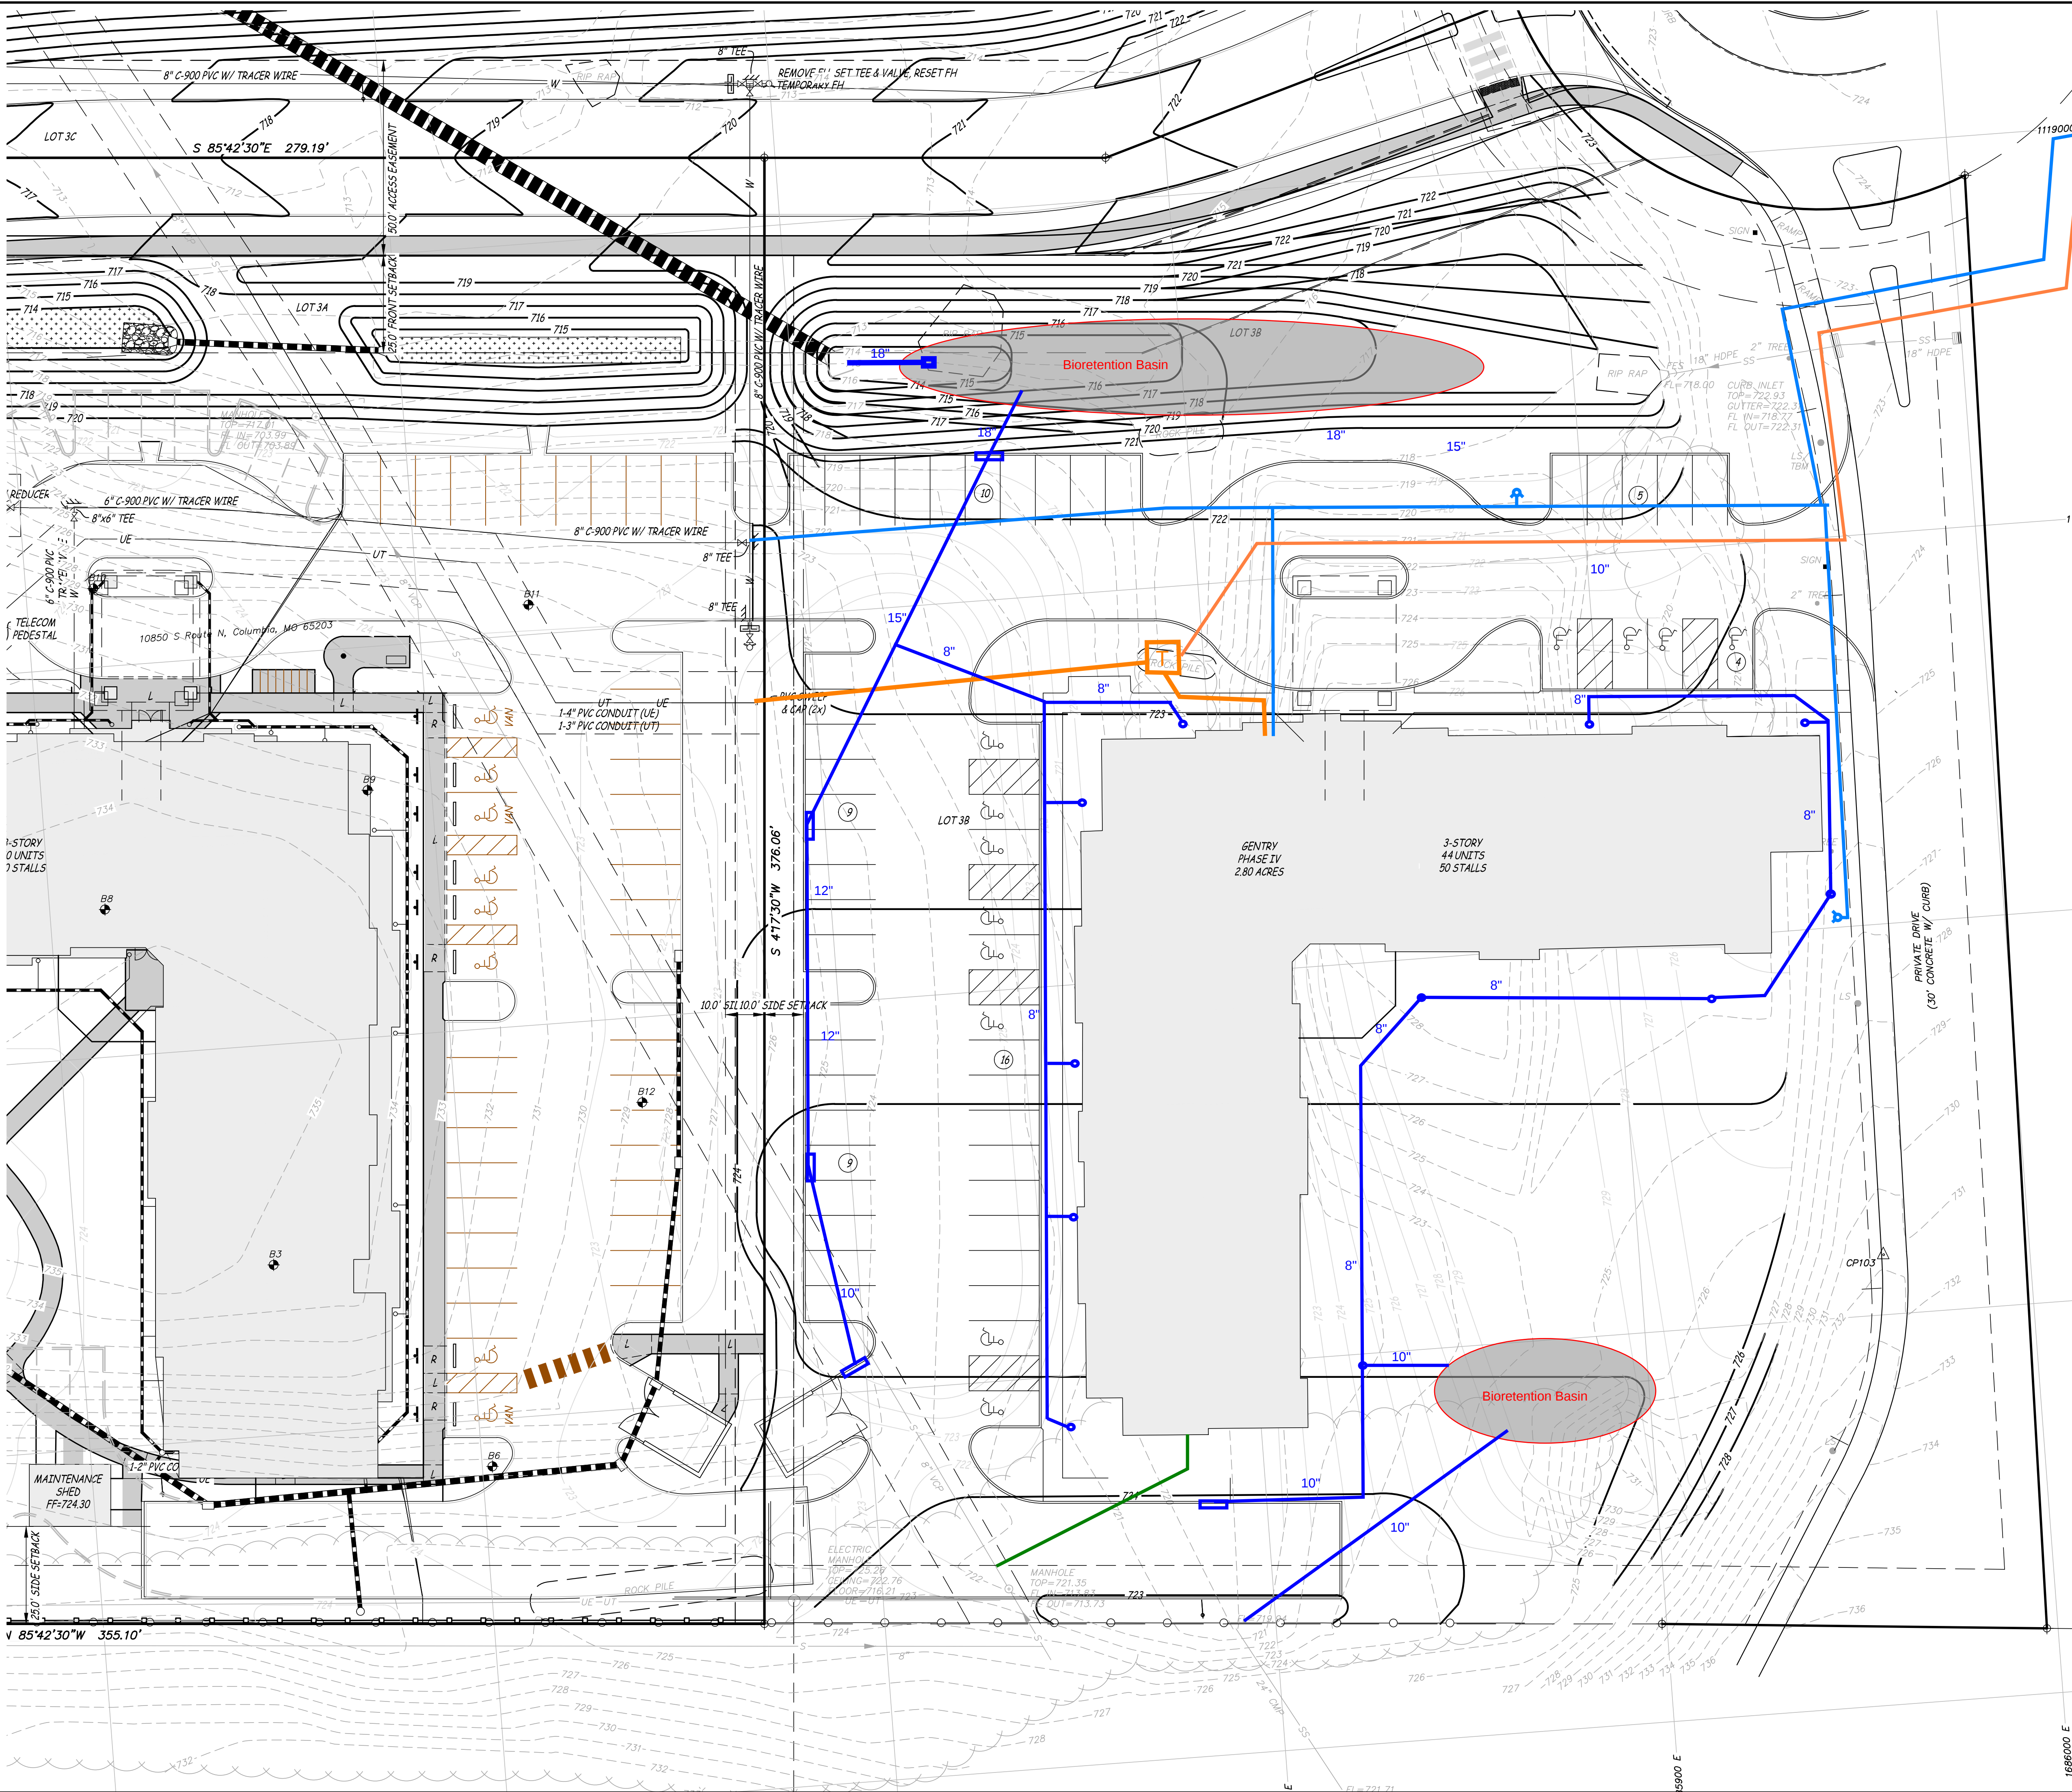

Water Line to be looped to
existing near Peach Ct
Electric Line to be looped to
existing near Peach Ct

ES&S
Engineering Surveys
& Services
DELIVERING YOUR VISION™
1113 Fay Street, Columbia, MO 65201
973-449-2646
802 El Dorado Drive, Jefferson City, MO 65101
873-636-3303
1775 West Main Street, Sedalia, MO 65301
660-826-8618
www.es-s-inc.com
MO Engineering Corp. # 2004005018

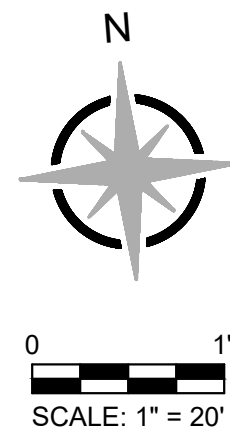

**AFFORDABLE EQUITY PARTNERS
GENTRY ESTATES PHASE III**
STREET ADDRESS
COLUMBIA, BOONE COUNTY, MISSOURI

THIS MEANS YOU CAN'T
RELY ON IT FOR
CERTIFIED DOCUMENT
PRELIMINARY
NOT FOR CONSTRUCTION
BUILDING RECORDS OR
PERMIT REVIEW PURPOSES

MATTHEW A. KRIETE
PROFESSIONAL ENGINEER
PE-2007002811

IF ORIGINAL SIGNATURE OR DIGITAL
AUTHENTICATION IS NOT PRESENT THIS
MEDIA SHOULD NOT BE CONSIDERED A
CERTIFIED DOCUMENT

Date
MARCH 18, 2024

Revised

Design: MK Drawn: CGH

Grading & Drainage Plan

Sheet

C2.01

ES&S PROJECT NO. 16191

30% DESIGN DEVELOPMENT PLANS